



ONE-FOURTH INCH = ONE FOOT
 ONE-HALF INCH = ONE FOOT
 ONE INCH = ONE FOOT
 ONE-QUARTER INCH = ONE FOOT
 THREE-FOURTHS INCH = ONE FOOT
 ONE AND ONE-HALF INCHES = ONE FOOT
 THREE INCHES = ONE FOOT

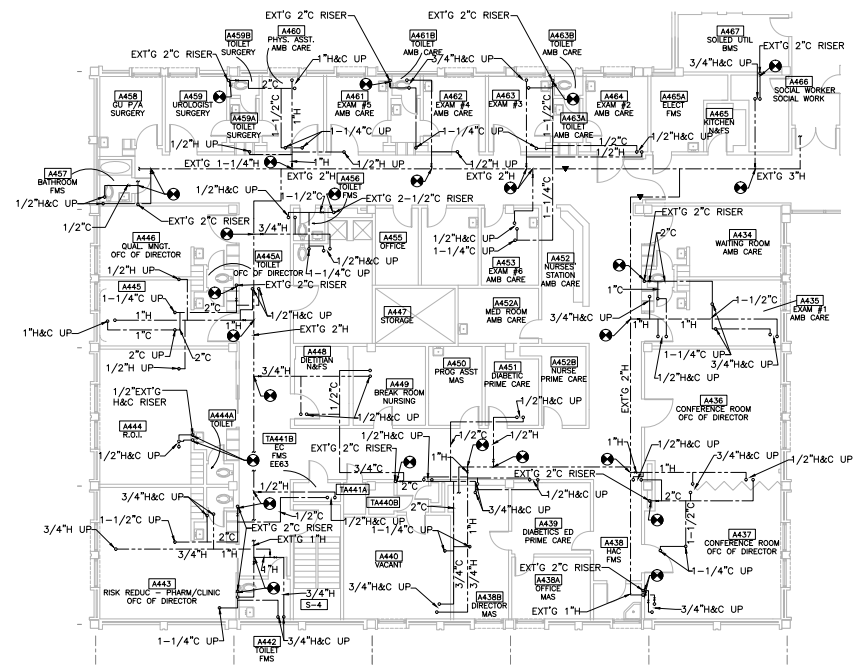

FOURTH FLOOR WARD EAST HOT AND COLD WATER PLAN
 SCALE: 1/8" = 1'-0"

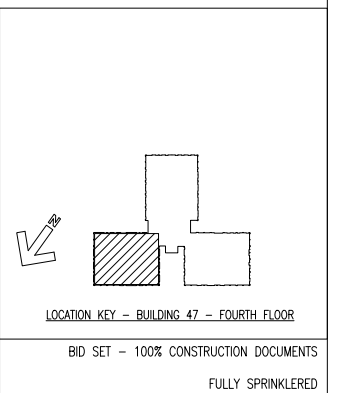

BY	REVISIONS	DATE



CONFIDENTIAL THESE DRAWINGS MUST BE RETURNED TO FACILITIES MANAGEMENT SERVICE, PROJECT SECTION, UPON COMPLETION, OR FURNISH USE BY THE CONTRACTOR FOR BIDDING PURPOSES.

ASBESTOS WARNING: ASBESTOS CONTAINING BUILDING MATERIALS (ACBM) ARE PRESENT THROUGHOUT THE FACILITY. IF CONTRACTORS FIND ACBM, OR SUSPECT FINDING ACBM, THEY SHALL IMMEDIATELY STOP WORK AND CONTACT THE PROJECT COOR.

SCALING NOTES: FULL SIZE V.A. "T" SHEETS (SCALE AS INDICATED) AND HALF SIZE V.A. "D" SHEETS (@ THE SCALE INDICATED LETTER SIZE DRAWINGS ARE NOT TO SCALE.

GENERAL NOTE: CONTRACTORS AND ARCHITECT/ENGINEERING FIRMS ARE RESPONSIBLE FOR THE FIELD VERIFICATION OF ALL EXISTING CONDITIONS.

Project Title
**RENOVATE
 WARD 5 EAST**

Drawing Title	Date	
FOURTH FLOOR - WARD EAST	12/21/12	
PLUMBING PLAN		
Building Number	Checked	Drawn
47	TMF	TPL
Location	ASHEVILLE, NC	

Project No.	DRAWING NO.
637-11-119	P104
Dwg	60 Of 78