



PLUMBING GENERAL NOTES
 1. SEE DRAWING P108 FOR FLOOR DRAIN DETAILS.

- DRAWING NOTES:**
1. PROVIDE SANITARY AND VENT ROUGH-IN FOR FUTURE CLINIC SERVICE SINK. NEW PIPING SHALL BE COMPLETELY INSTALLED INSIDE WALL AND COVERED BY NEW 22" SQUARE ACCESS PANEL, ACUDOR PA-3000 OR EQUAL.
 2. PROVIDE DOMESTIC COLD WATER PIPING ROUGH-IN FOR FUTURE CLINIC SERVICE SINK. NEW PIPING SHALL BE COMPLETELY INSTALLED INSIDE WALL AND COVERED BY NEW 22" SQUARE ACCESS PANEL, ACUDOR PA-3000 OR EQUAL.
 3. PROVIDE 1" DOMESTIC COLD WATER PIPING AND ISOLATION BALL VALVE IN CEILING SPACE ABOVE TOILET ROOM FOR CONNECTION BY MECHANICAL CONTRACTOR FOR SERVICE TO ROOF MOUNTED AIR HANDLING UNIT HUMIDIFIER CLEAN STEAM GENERATOR.

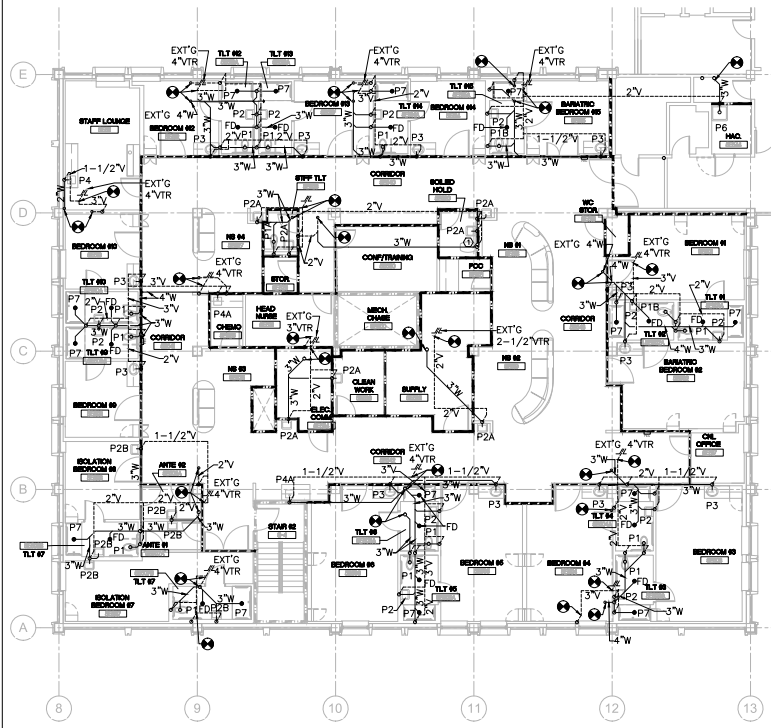

FIFTH FLOOR WARD EAST WASTE AND VENT PLAN
 SCALE: 1/8" = 1'-0"

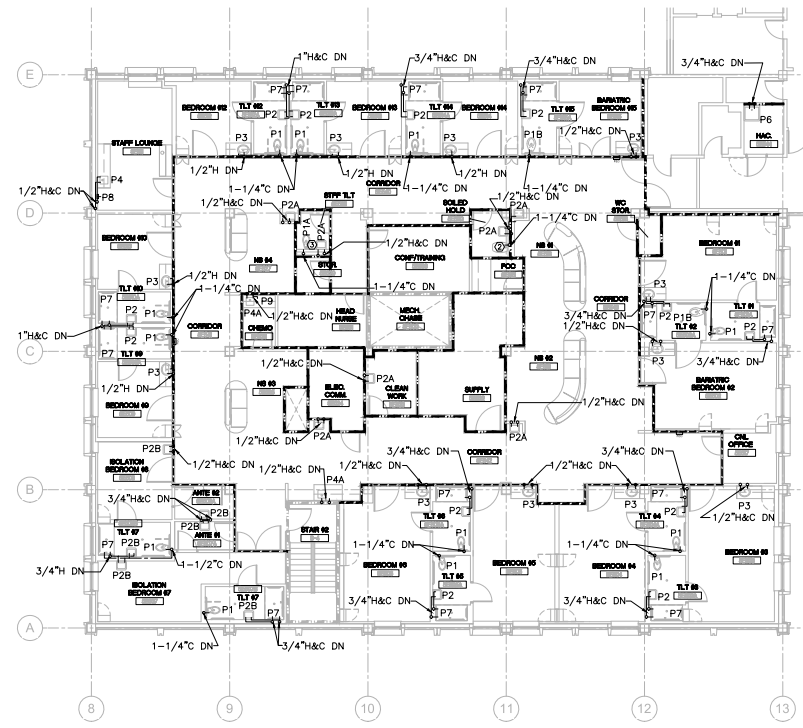


FIFTH FLOOR WARD EAST HOT AND COLD WATER PLAN
 SCALE: 1/8" = 1'-0"


100% SUBMITTAL
 BID SET -
 CONSTRUCTION
 DOCUMENTS
 DATE: DECEMBER, 21 2012

WALL LEGEND

- SMOKE RESISTIVE, POSITIVE LATCHING CLOSER
- SMOKE PARTITION (HAZARDOUS), 3/4 HR. LBL.
- SMOKE BARRIER (1 HOUR FIRE RESISTANCE RATED), 3/4 HR. LBL, HOLD OPENS
- 1-HOUR FIRE RESISTANCE RATED BARRIER (HAZ.), 3/4 HR. LBL, CLOSER
- EXISTING TO REMAIN 2-HOUR FIRE RATED

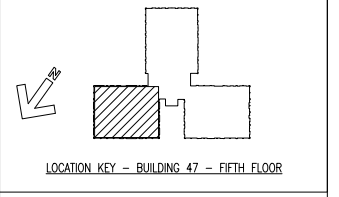

BID SET - 100% CONSTRUCTION DOCUMENTS

 

FULLY SPRINKLERED

BY	REVISIONS	DATE



CONFIDENTIAL THESE DRAWINGS MUST BE RETURNED TO FACILITIES MANAGEMENT SERVICE, PROJECT SECTION, UPON COMPLETION, OR FINAL USE BY THE CONTRACTOR FOR BIDDING PURPOSES.

ASBESTOS WARNING: ASBESTOS CONTAINING BUILDING MATERIALS (ACBM) ARE PRESENT THROUGHOUT THE FACILITY. IF CONTRACTORS FIND ACBM, OR SUSPECT FINDING ACBM, THEY SHALL IMMEDIATELY STOP WORK AND CONTACT THE PROJECT COTR.

SCALING NOTES: FULL SIZE V.A. T" SHEETS (SCALE AS INDICATED) AND HALF SIZE V.A. "D" SHEETS (3/4 OF THE SCALE INDICATED LETTER SIZE DRAWINGS ARE NOT TO SCALE.

GENERAL NOTE: CONTRACTORS AND ARCHITECT/ENGINEERING FIRMS ARE RESPONSIBLE FOR THE FIELD VERIFICATION OF ALL EXISTING CONDITIONS.

Project Title
**RENOVATE
 WARD 5 EAST**

Drawing Title FIFTH FLOOR - WARD EAST PLUMBING PLANS	Date 12/21/12
Building Number 47	Project No. 637-11-119
Location ASHEVILLE, NC	DRAWING NO. P105
Checked TMF	Dwg 61 OF 78

